


GREAT BARRIER REEF FILM FESTIVAL
MAGNETIC ISLAND ARCADIA HOTEL CONFERENCE ROOM
FLOOR PLAN

SCALE :- 1:100 NOMINAL
DATE:- 10/08/16

DWG.NO. **SK 2**
DRAWN:- BECKETT

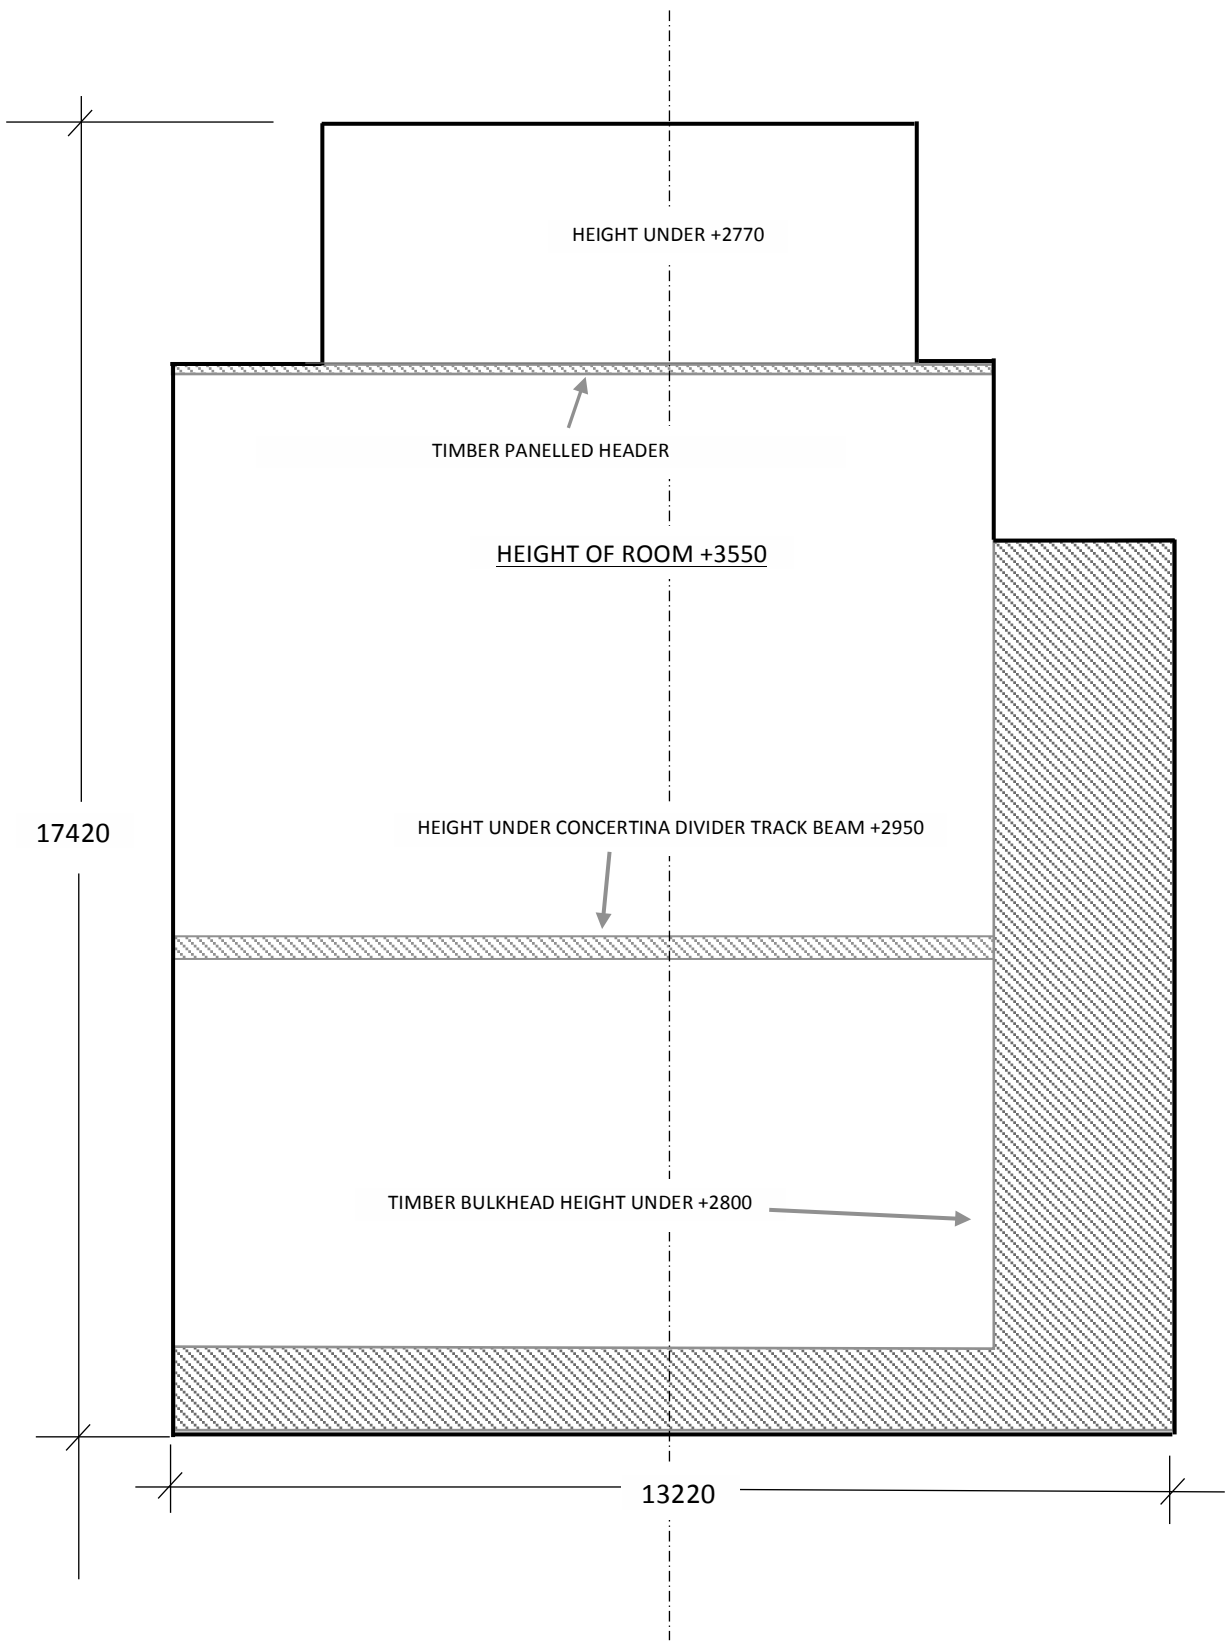

GREAT BARRIER REEF FILM FESTIVAL

MAGNETIC ISLAND ARCADIA HOTEL CONFERENCE ROOM


CEILING PLAN



SCALE :- 1:100 NOMINAL

DATE:- 10/08/16

DWG.NO. SK 3

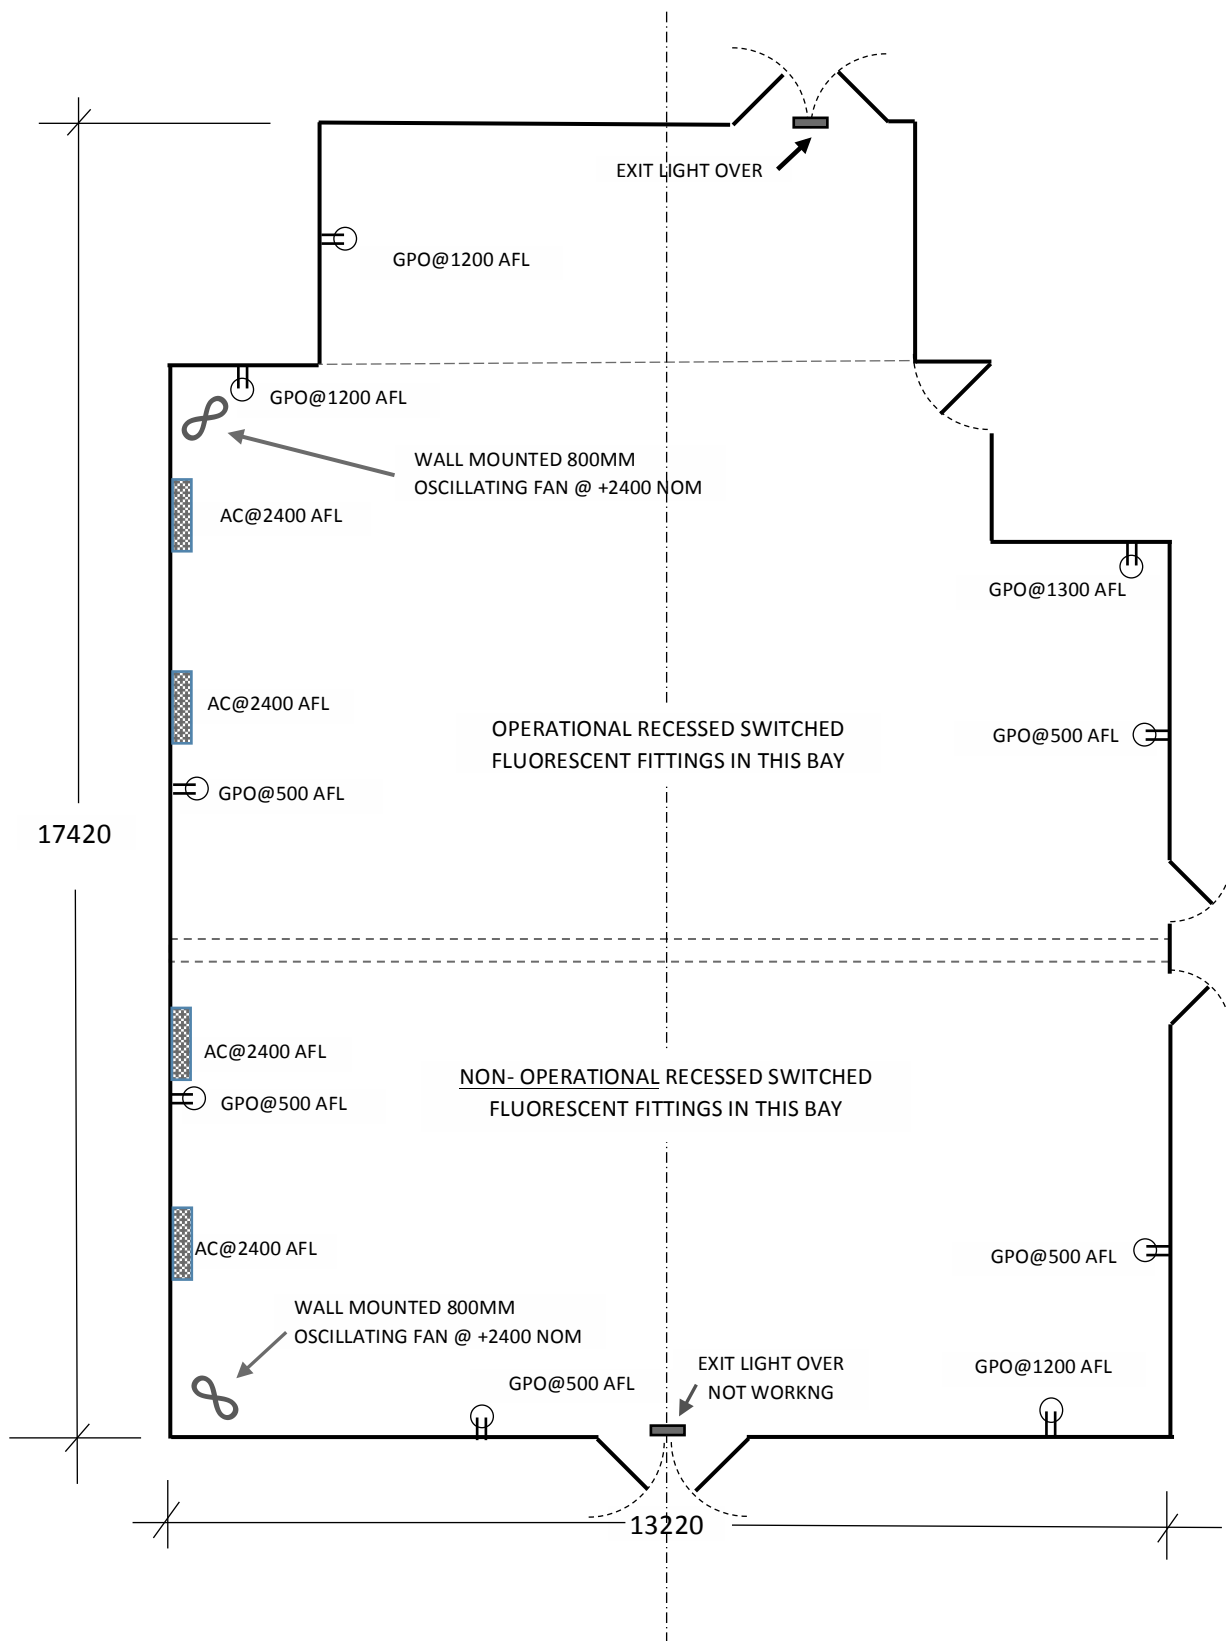DRAWN:- BECKETT



-  DOUBLE GANGED 10 AMP GPO
-  AC UNIT

GREAT BARRIER REEF FILM FESTIVAL
MAGNETIC ISLAND ARCADIA HOTEL CONFERENCE ROOM
ELECTRICAL LAYOUT

SCALE :- 1:100 NOMINAL DWG.NO. **SK4**
DATE:- 10/08/16 DRAWN:- BECKETT